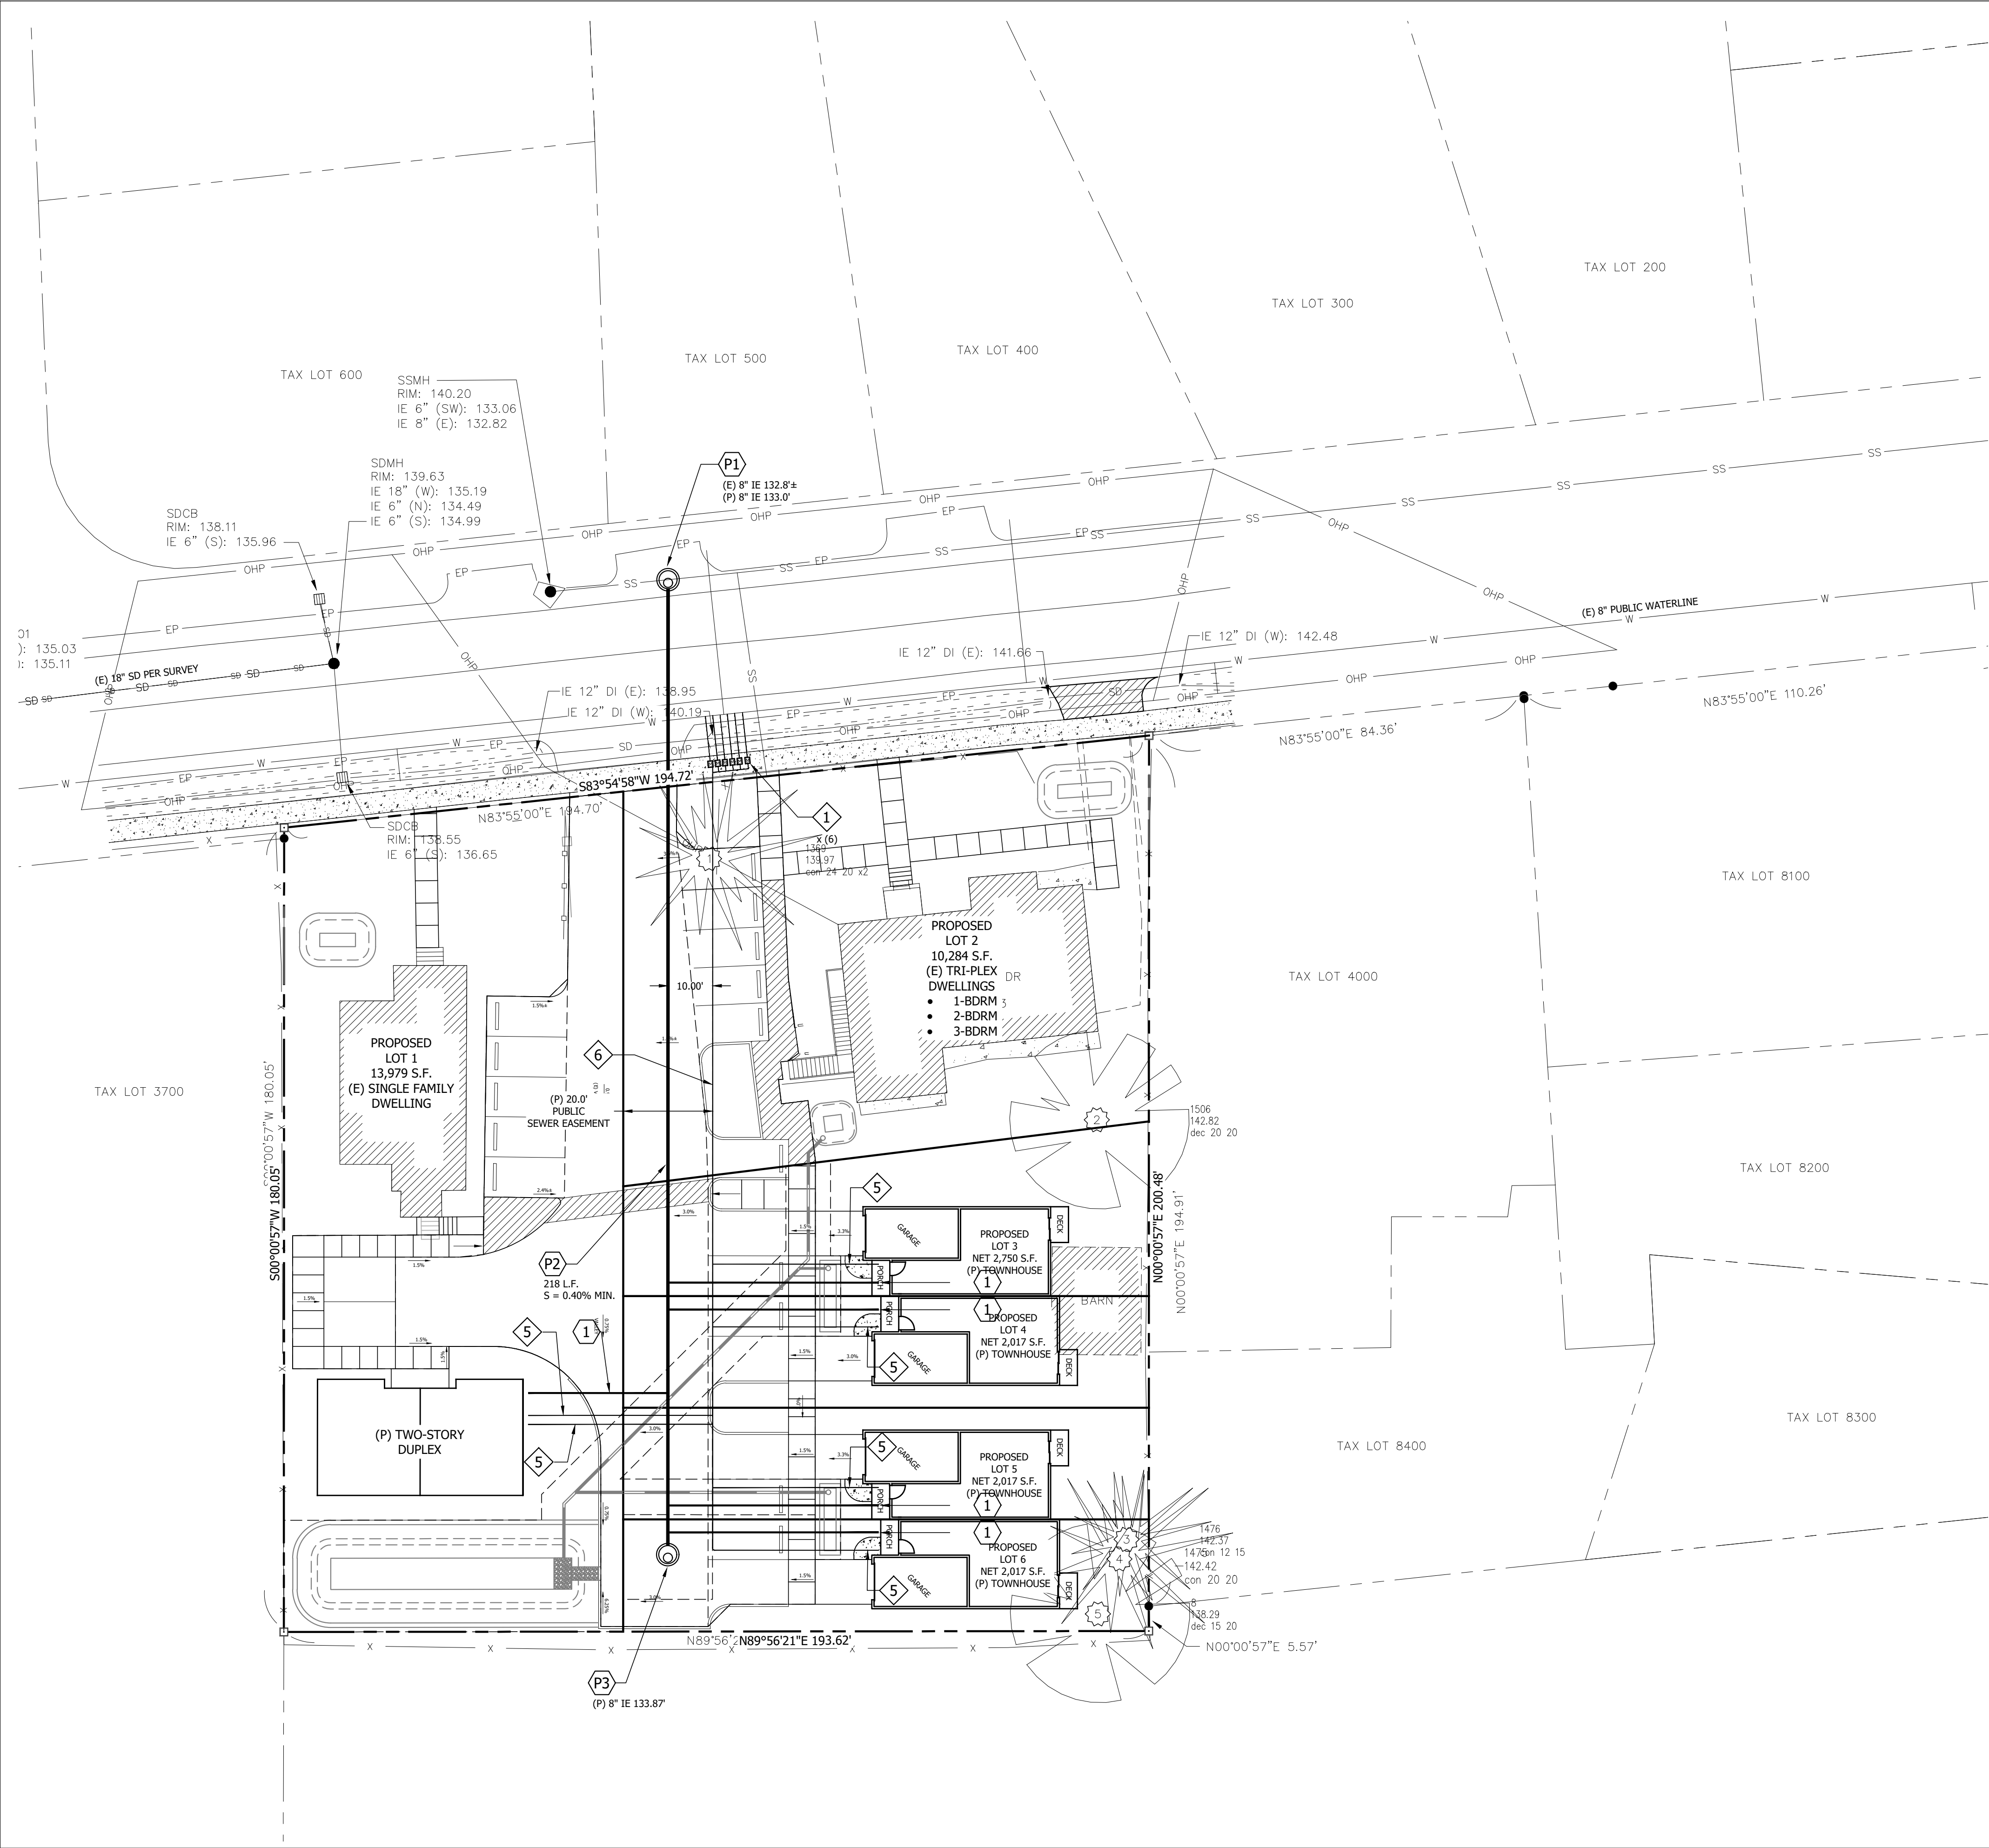


- PUBLIC SEWER NOTES**
- P1** INSTALL NEW PUBLIC SANITARY SEWER MANHOLE OVER THE EXISTING 8" PUBLIC SANITARY SEWER PIPE PER CITY OF KEIZER STANDARDS.
 - P2** INSTALL PUBLIC 8" PVC D3034 SANITARY SEWER PER CITY OF KEIZER STANDARDS.
 - P3** INSTALL NEW PUBLIC SANITARY SEWER MANHOLE PER CITY OF KEIZER STANDARDS.


- PRIVATE SEWER NOTES**
- 1** INSTALL 4" PRIVATE PVC SEWER PIPE PER CURRENT STATE OF OREGON PLUMBING SPECIALTY CODE. MIN. SLOPE = 2.0%, INSTALL TRACER WIRE.

- PUBLIC WATER NOTES**
- 1** INSTALL PUBLIC 1-INCH WATER SERVICE TAP, 1-INCH WATER SERVICE, METER BOX AND ANGLE METER STOP PER CITY OF KEIZER STANDARDS.

- PRIVATE WATER NOTES**
- 5** INSTALL PRIVATE PVC DOMESTIC WATER LINE PER CURRENT STATE OF OREGON PLUMBING SPECIALTY CODE FOR DOMESTIC BUILDING WATER. SIZE TO BE DETERMINED WITH BUILDING PERMIT SUBMITTAL.
 - 6** INSTALL MULTIPLE PRIVATE WATERLINES IN JOINT TRENCH.

THIS MAP WAS MADE FOR
PRELIMINARY PLANNING PURPOSES
ONLY. NOT TO BE USED FOR
CONSTRUCTION.

PLAN REVISIONS	DATE

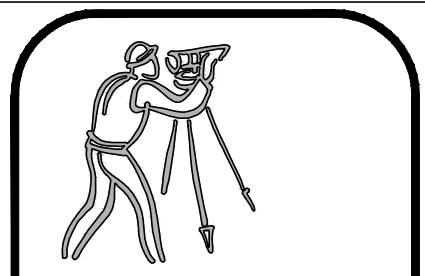

CLIENT:
BRANDON HALL
22265 SW TAYLORS DR
TUALATIN, OR 97062
503-924-9777

**UDELL ENGINEERING
AND
LAND SURVEYING, LLC**
63 EAST ASH ST.
LEBANON, OREGON 97355
(541) 451-5125 PH.
(541) 451-1366 FAX

PRELIMINARY UTILITY PLAN

**1190-1210 ALDER DR. NE
RESIDENTIAL DEVELOPMENT
KEIZER, OREGON**

DATE: SEPTEMBER 17, 2024
PROJECT: 20-308 HALL KEIZER
DRAWN BY: BSV/MLM
CHECKED BY: BSV

Sheet **H**
SCALE: SEE BARSCALE